
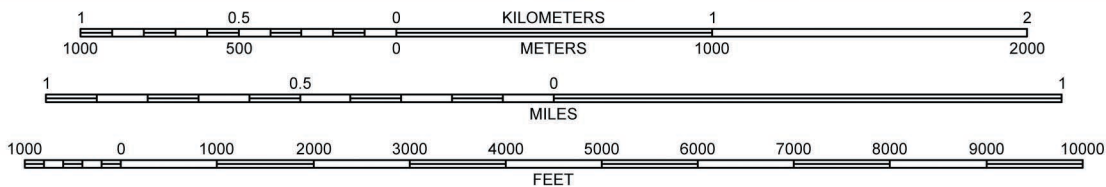


APPENDIX C


KENT STATE TRUMBULL CAMPUS MAPS

- Trumbull Campus Site Location Map (C-1)
- Trumbull Campus Site Plan – Maintenance (C-2)
- Trumbull Campus Site Drainage Map – Maintenance (C-3)
- Trumbull Campus Drainage Map (C-4)

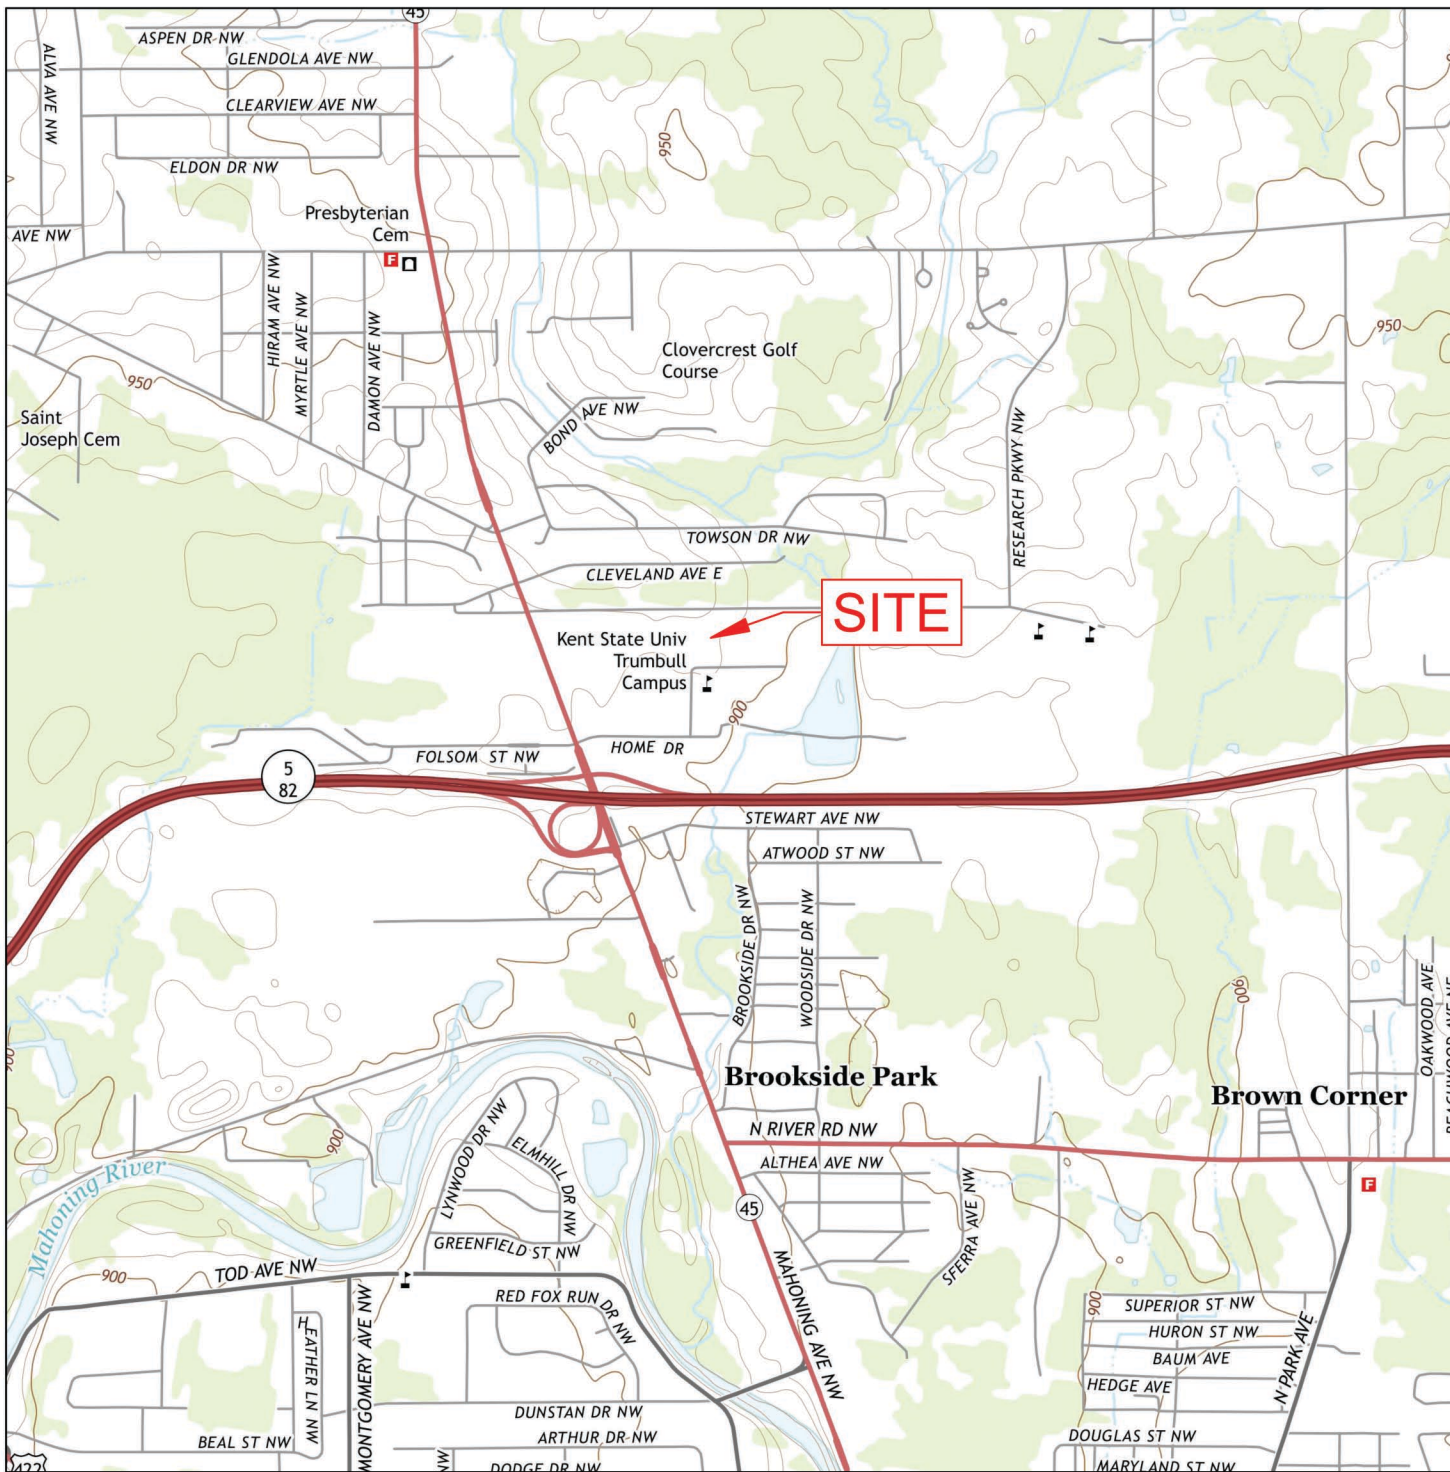

QUADRANGLE LOCATION

West Farmington	Bristolville	Gustavus
Southington	Champion	Cortland
Newton Falls	Warren	Girard

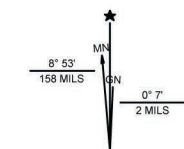

UTM GRID AND 2013 MAGNETIC NORTH DECLINATION AT CENTER OF SHEET

Base Map Source (South):

USGS 7 1/2 Minute Topographic
Quadrangle Map
Champion, OH, 2013

Reference:

Kent State University Trumbull Campus
4314 MaHoning Avenue NW
Warren, OH 44483



**ENVIRONMENTAL QUALITY
MANAGEMENT, INC.**


1800 CARILLON BLVD., CINCINNATI, OHIO 45240
PHONE 513.825.7500 | FAX 513.825.7495
WWW.EQM.COM

DRAWN	R. RUSSELL	03-03-2015
CHECKED	S. HICKS	03-04-2015
APPROVED	J. BINZER	03-05-2015

SCALE: 1" = 2000'

**KENT STATE UNIVERSITY
TRUMBULL CAMPUS
SITE LOCATION MAP**

SIZE	PROJECT NO.	DWG NO.	REV
A	040198.0005		0

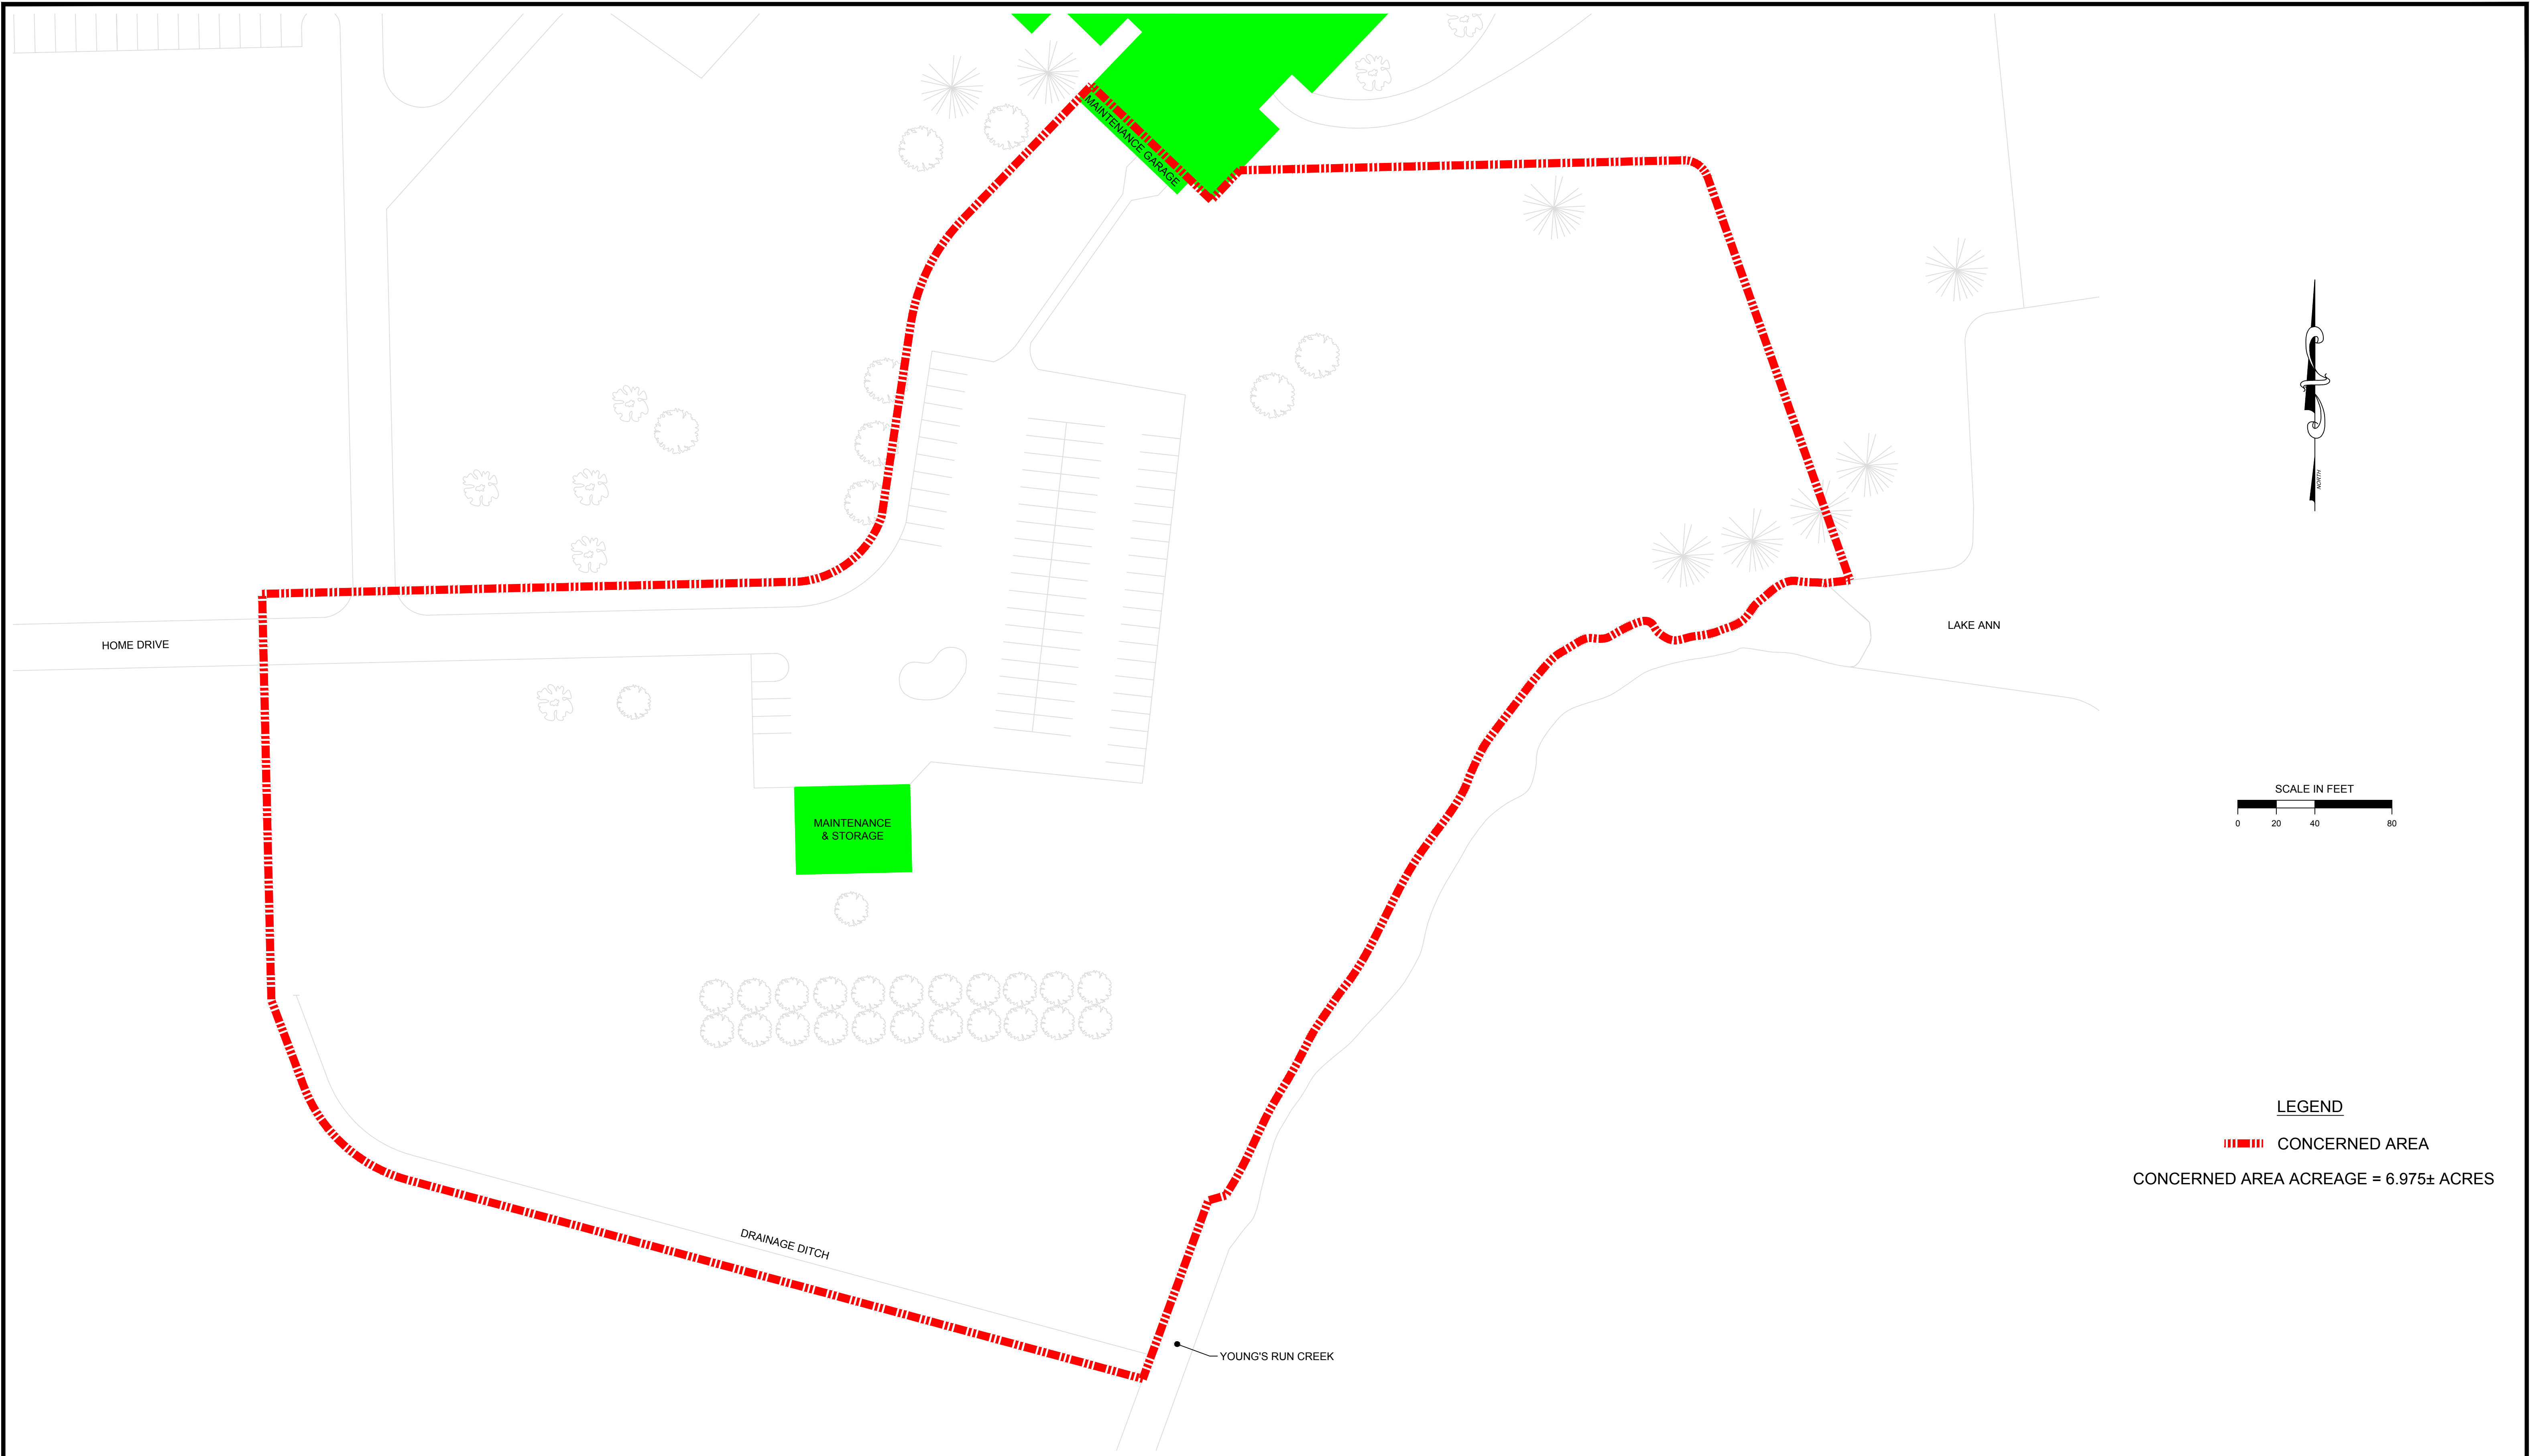

LEGEND

■■■■ CONCERNED AREA

CONCERNED AREA ACREAGE = 6.975± ACRES


REV	DESCRIPTION	DATE	APPROVED
REVISIONS			



**ENVIRONMENTAL QUALITY
MANAGEMENT, INC.**
1800 CARILLON BLVD., CINCINNATI, OHIO 45240
PHONE 513.825.7500 | FAX 513.825.7495
WWW.EQM.COM

DRAWN	R. RUSSELL	03-03-2015
CHECKED	S. HICKS	03-04-2015
APPROVED	□ BIN/ER	03-05-2015
SCALE:	1" = 40'	

KENT STATE UNIVERSITY TRUMBULL CAMPUS SITE PLAN			
SIZE	PROJECT NO.	DWG NO.	REV
D	040198.0005		0

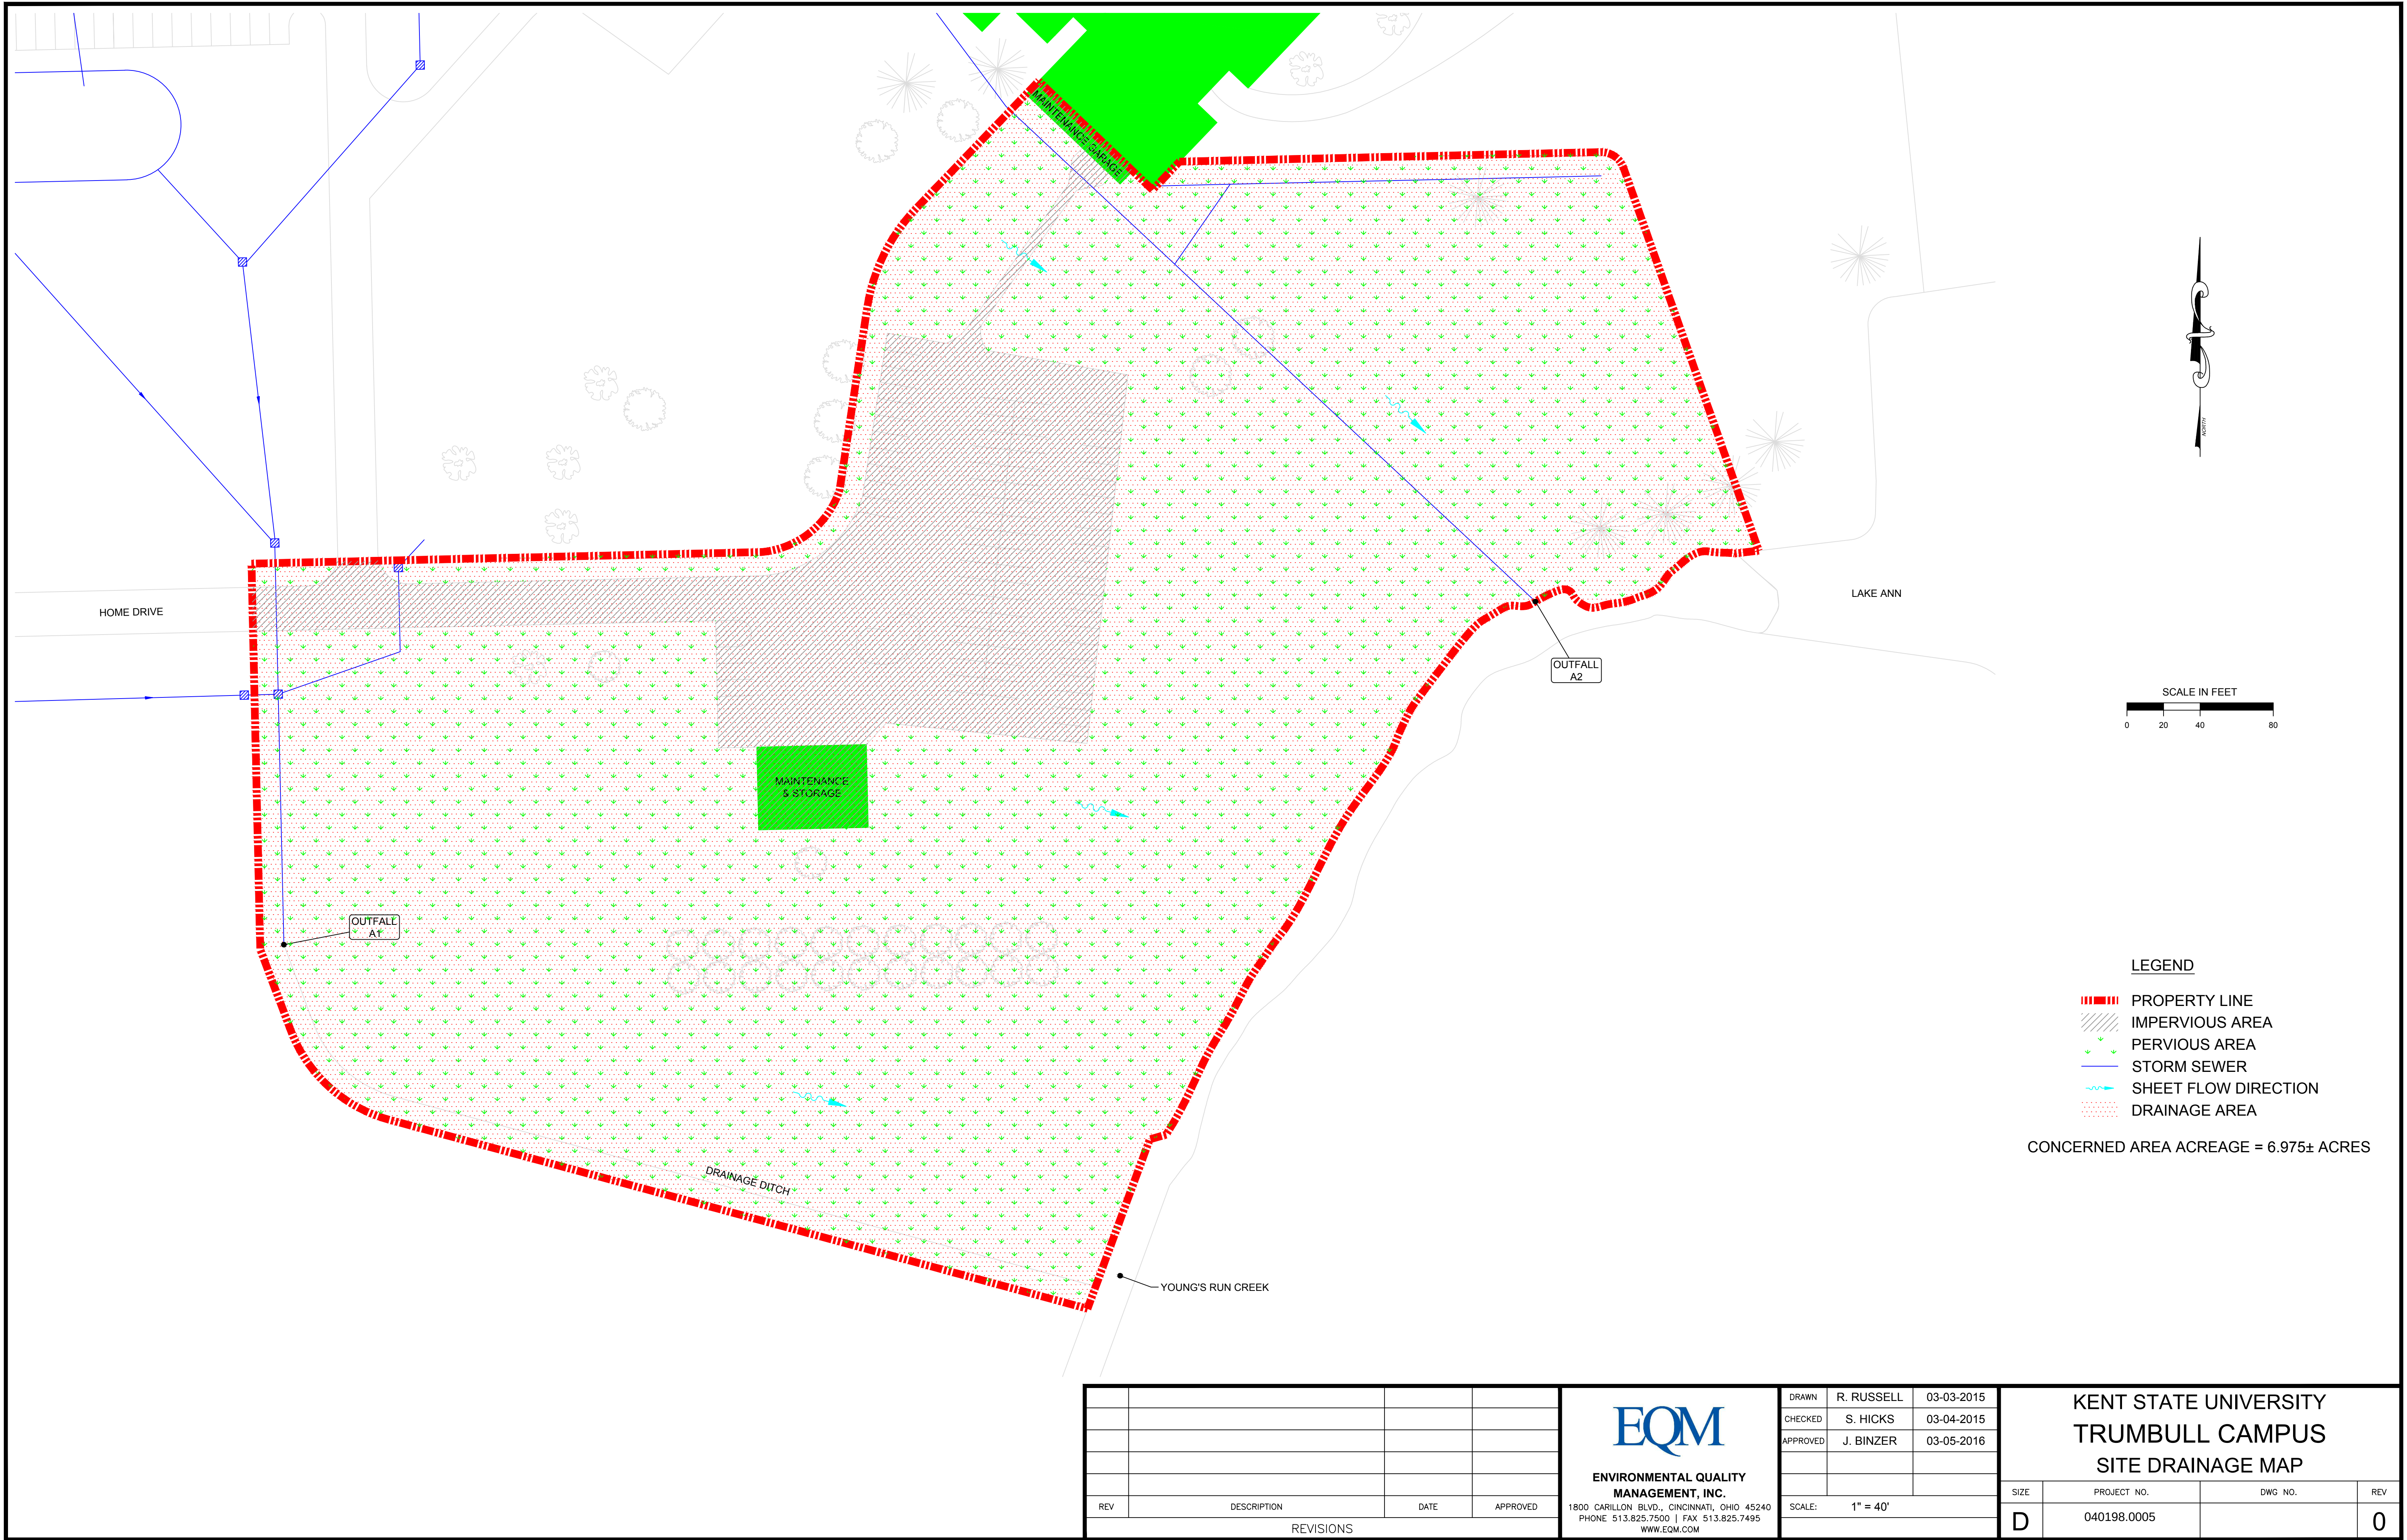

LEGEND

- PROPERTY LINE
- IMPERVIOUS AREA
- PERVIOUS AREA
- STORM SEWER
- SHEET FLOW DIRECTION
- DRAINAGE AREA

CONCERNED AREA ACREAGE = 6.975± ACRES


REV	DESCRIPTION	DATE	APPROVED
REVISIONS			



**ENVIRONMENTAL QUALITY
MANAGEMENT, INC.**
1800 CARILLON BLVD., CINCINNATI, OHIO 45240
PHONE 513.825.7500 | FAX 513.825.7495
WWW.EQM.COM

DRAWN	R. RUSSELL	03-03-2015
CHECKED	S. HICKS	03-04-2015
APPROVED	J. BINZER	03-05-2016
SCALE:	1" = 40'	

KENT STATE UNIVERSITY TRUMBULL CAMPUS SITE DRAINAGE MAP			
SIZE	PROJECT NO.	DWG NO.	REV
D	040198.0005		0

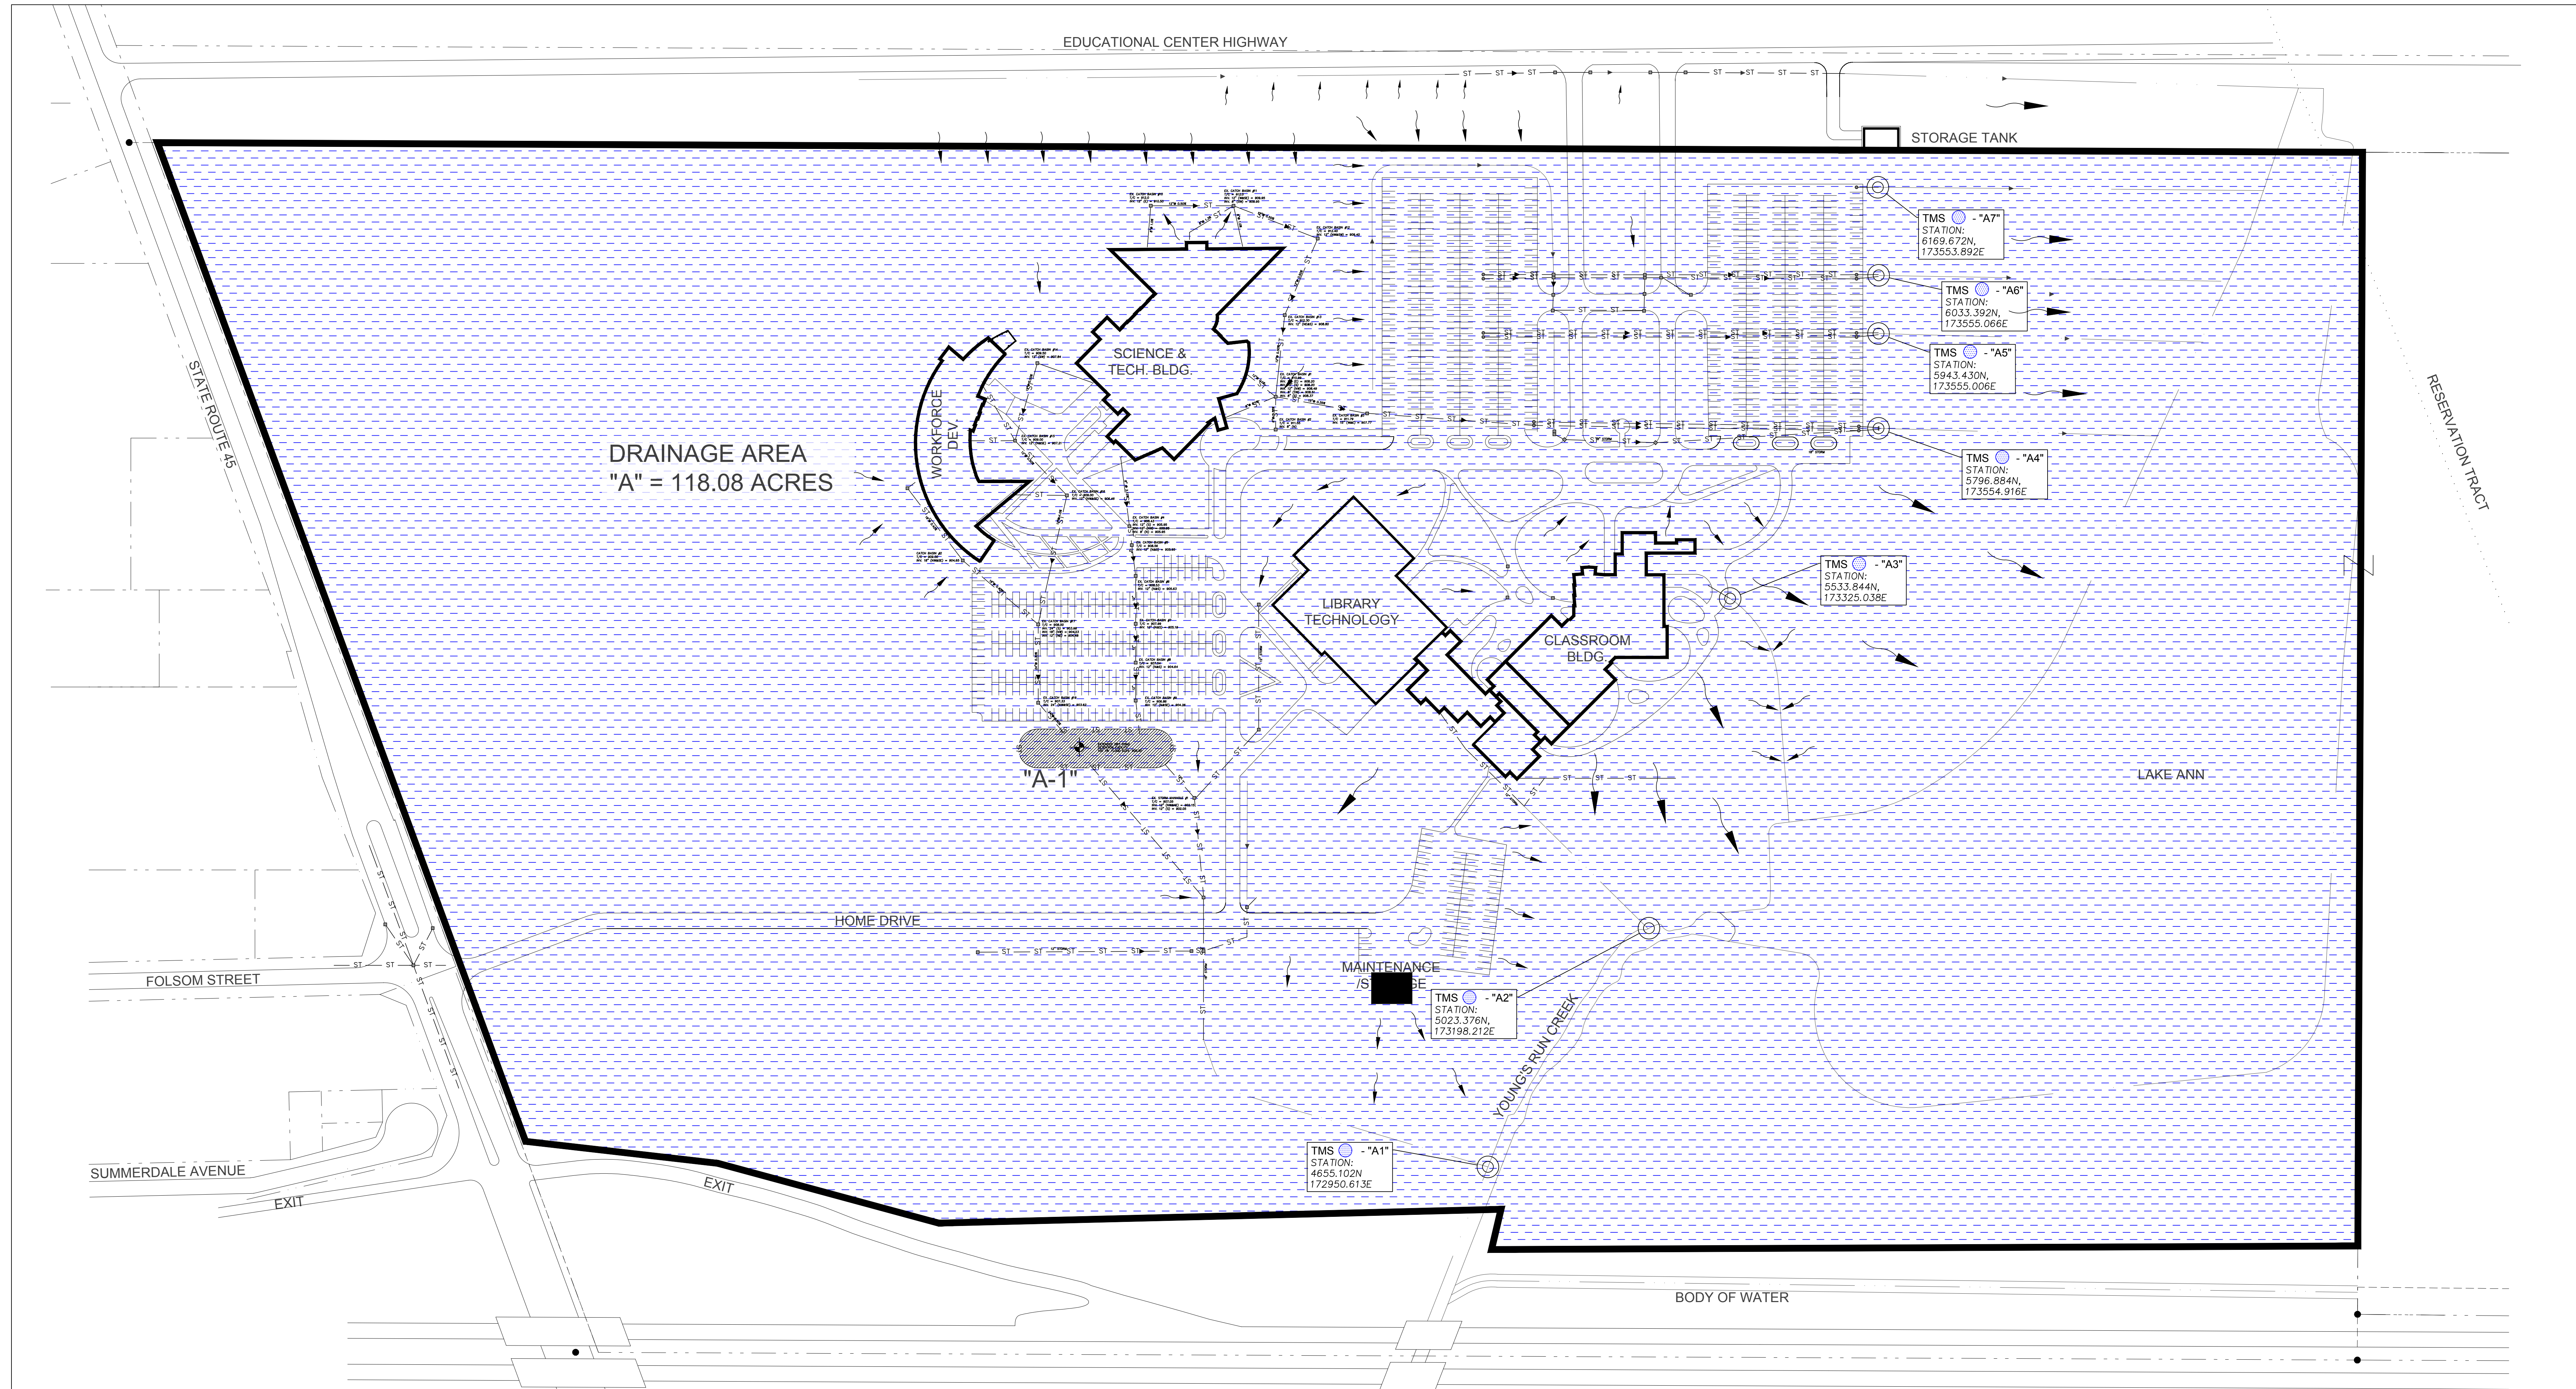

KENT STATE UNIVERSITY
TRUMBULL CAMPUS
STORM DRAINAGE
MS4 MAPPING
SCALE 1"=100'
MARCH 2015
UPDATED: MARCH 2018

OUTFALL SUMMARY		
LABEL	DRAINAGE AREA	STATION
A1	DRAINAGE AREA "A"	4655.102N, 172950.613E
A2	DRAINAGE AREA "A"	5023.376N, 173198.212E
A3	DRAINAGE AREA "A"	5533.844N, 173325.038E
A4	DRAINAGE AREA "A"	5796.884N, 173554.916E
A5	DRAINAGE AREA "A"	5943.430N, 173555.006E
A6	DRAINAGE AREA "A"	6033.392N, 173555.066E
A7	DRAINAGE AREA "A"	6169.672N, 173553.892E

LEGEND	
	STREAM/CREEK
	OUTFALL
	PROPERTY LINE
	STORMWATER MANAGEMENT FACILITY
	FLOW ARROWS

BMP SUMMARY		
LABEL	DESCRIPTION	STATION
A1	EXTENDED DRY POND DETENTION FACILITY	5304.067N, 172319.185E
	CATCH BASIN	VARIOUS

CITY OF WARREN MS4 DISTRICT
TRUMBULL COUNTY SOIL & WATER
KENT STATE UNIVERSITY
TRUMBULL CAMPUS
MS4 MAPPING
C001